


A1

FOUNDATION PLAN

SCALE:1/4" = 1'-0"

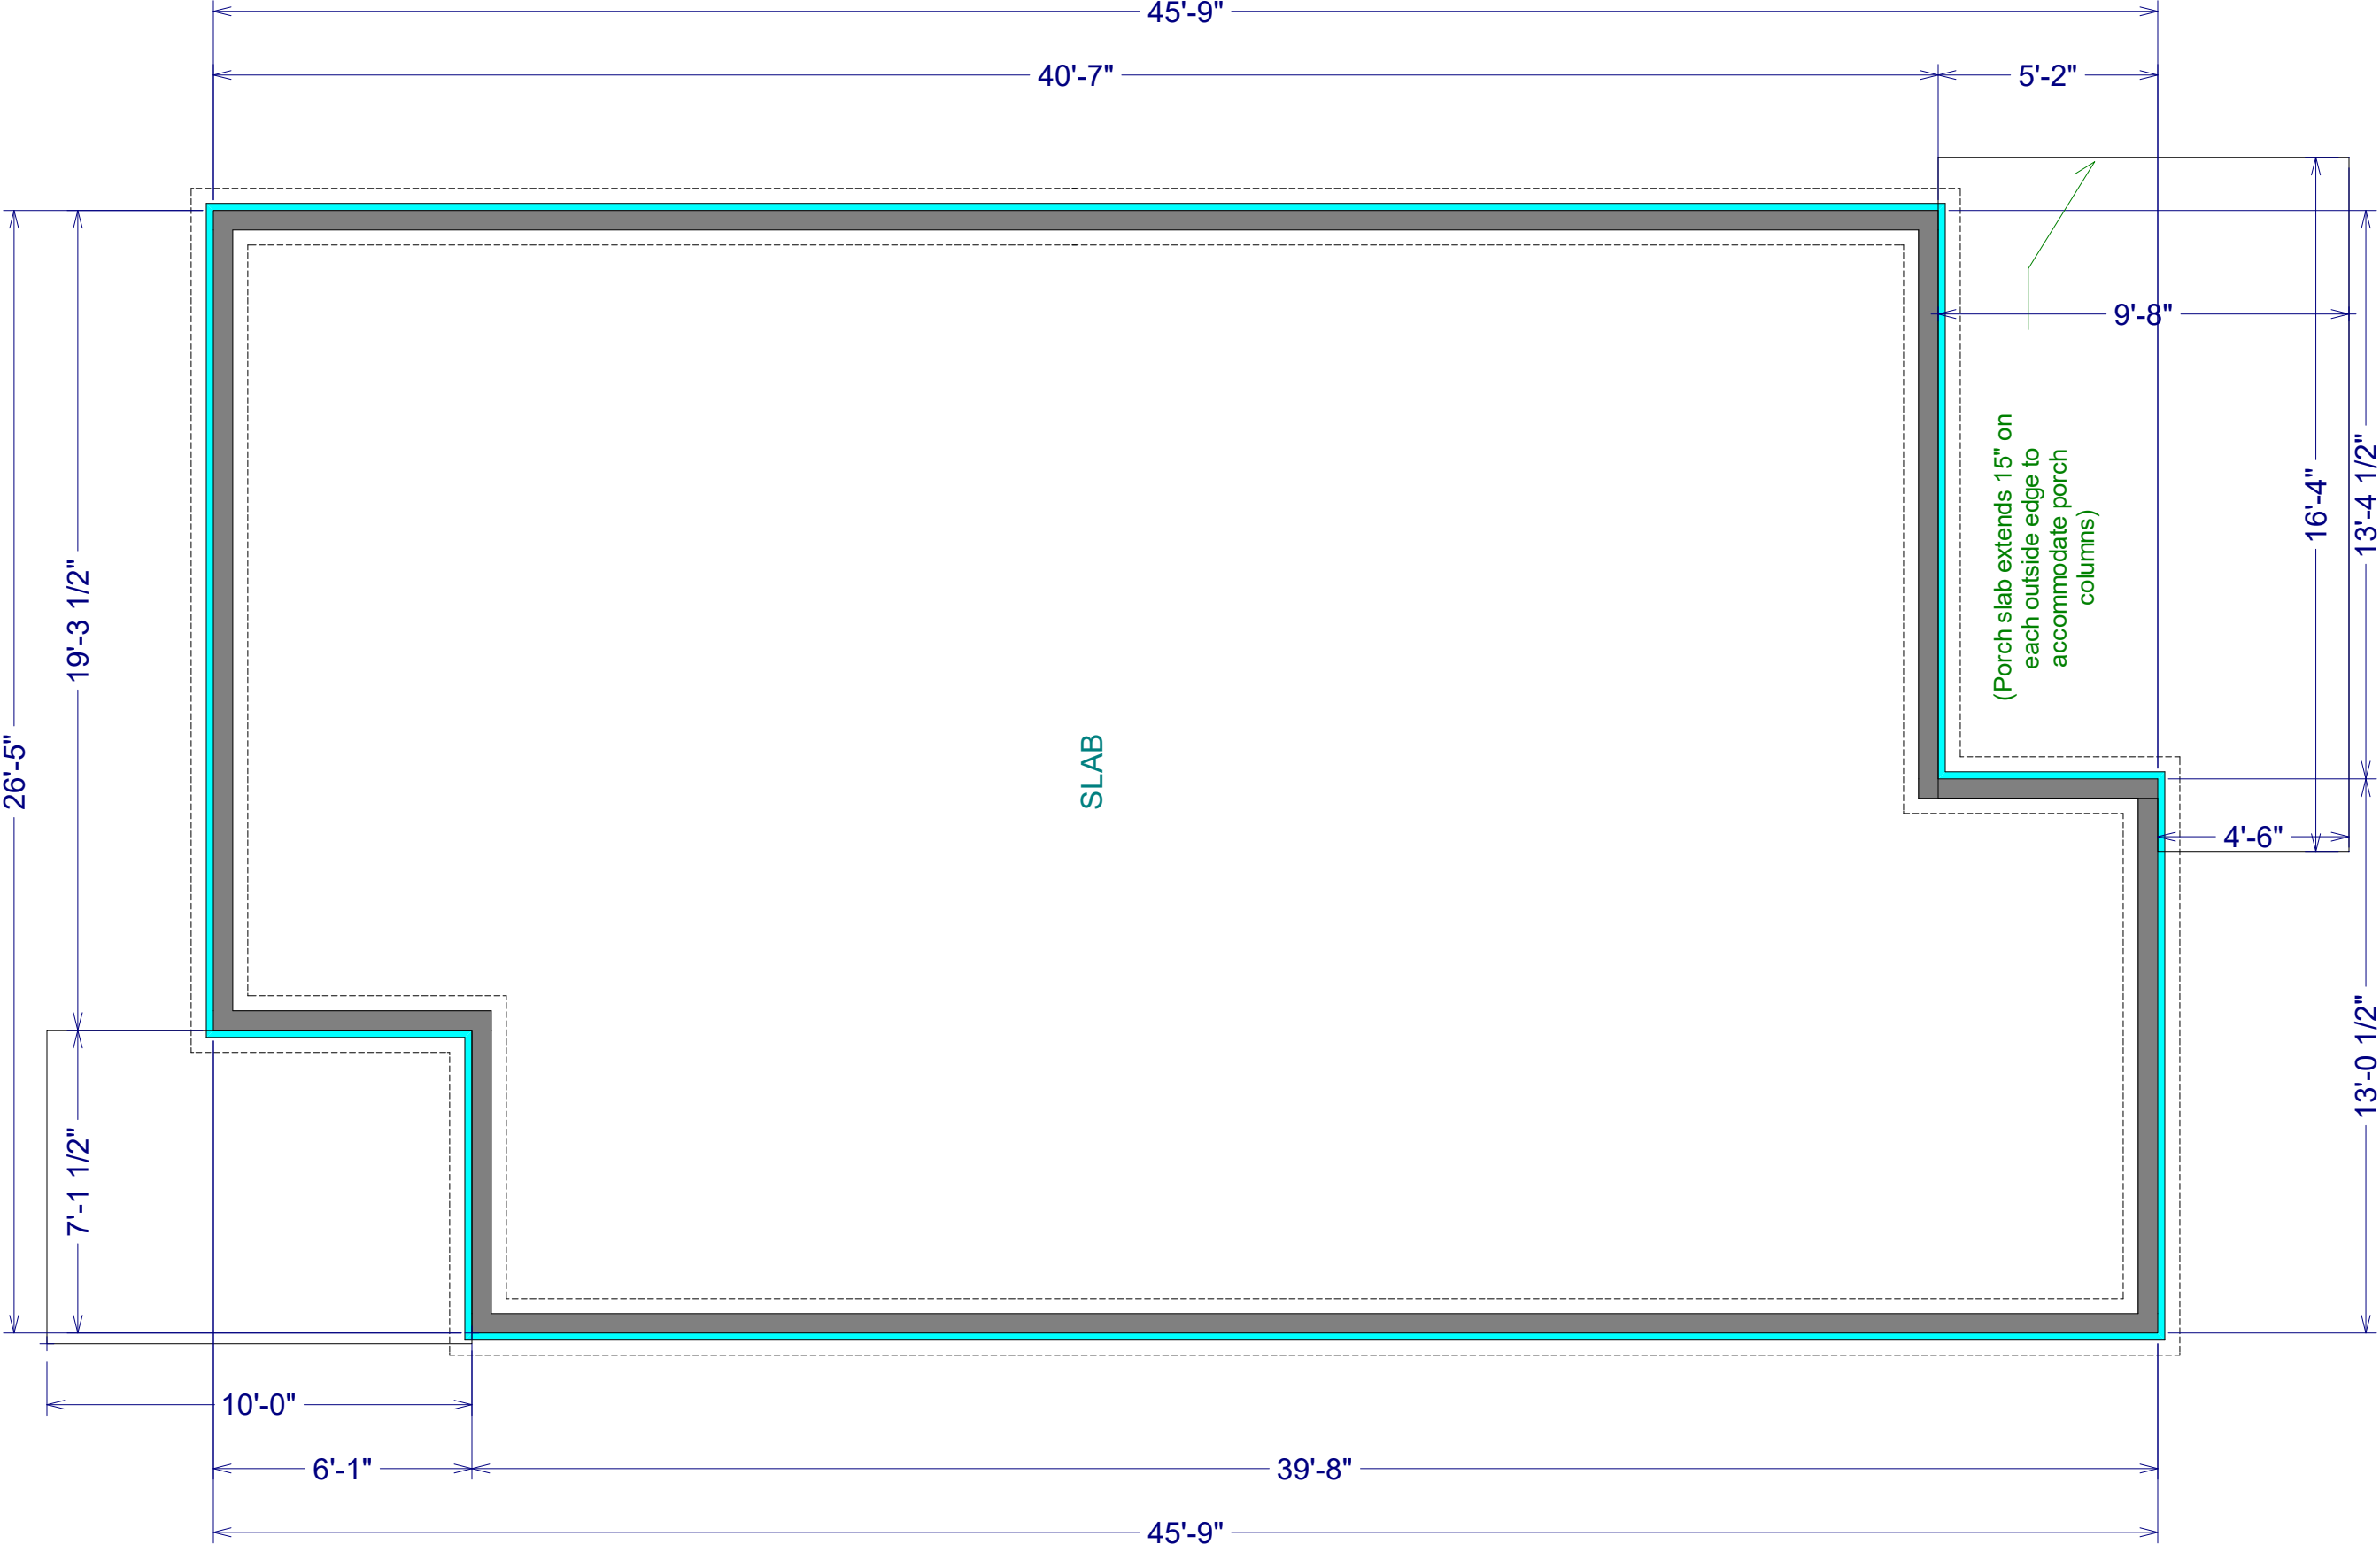

LIVING AREA
1097 sf
Rev. 4/24/2019

6/13/2019

A2

PARK PRESERVE FALL 2019
LOT 324: 4129 POLK FOREST CR
STYLE: PKP301
3 BEDROOM/2 BATHROOM
1097 sf


PERMIT NO.:
2019024808

HABITAT FOR HUMANITY
414 HARDING PLACE, SUITE 100
NASHVILLE, TN 37211
OFFICE: 615-254-HOME
FAX: 615-254-4645



A1

FLOORING
SCALE: 1/4" = 1'-0"

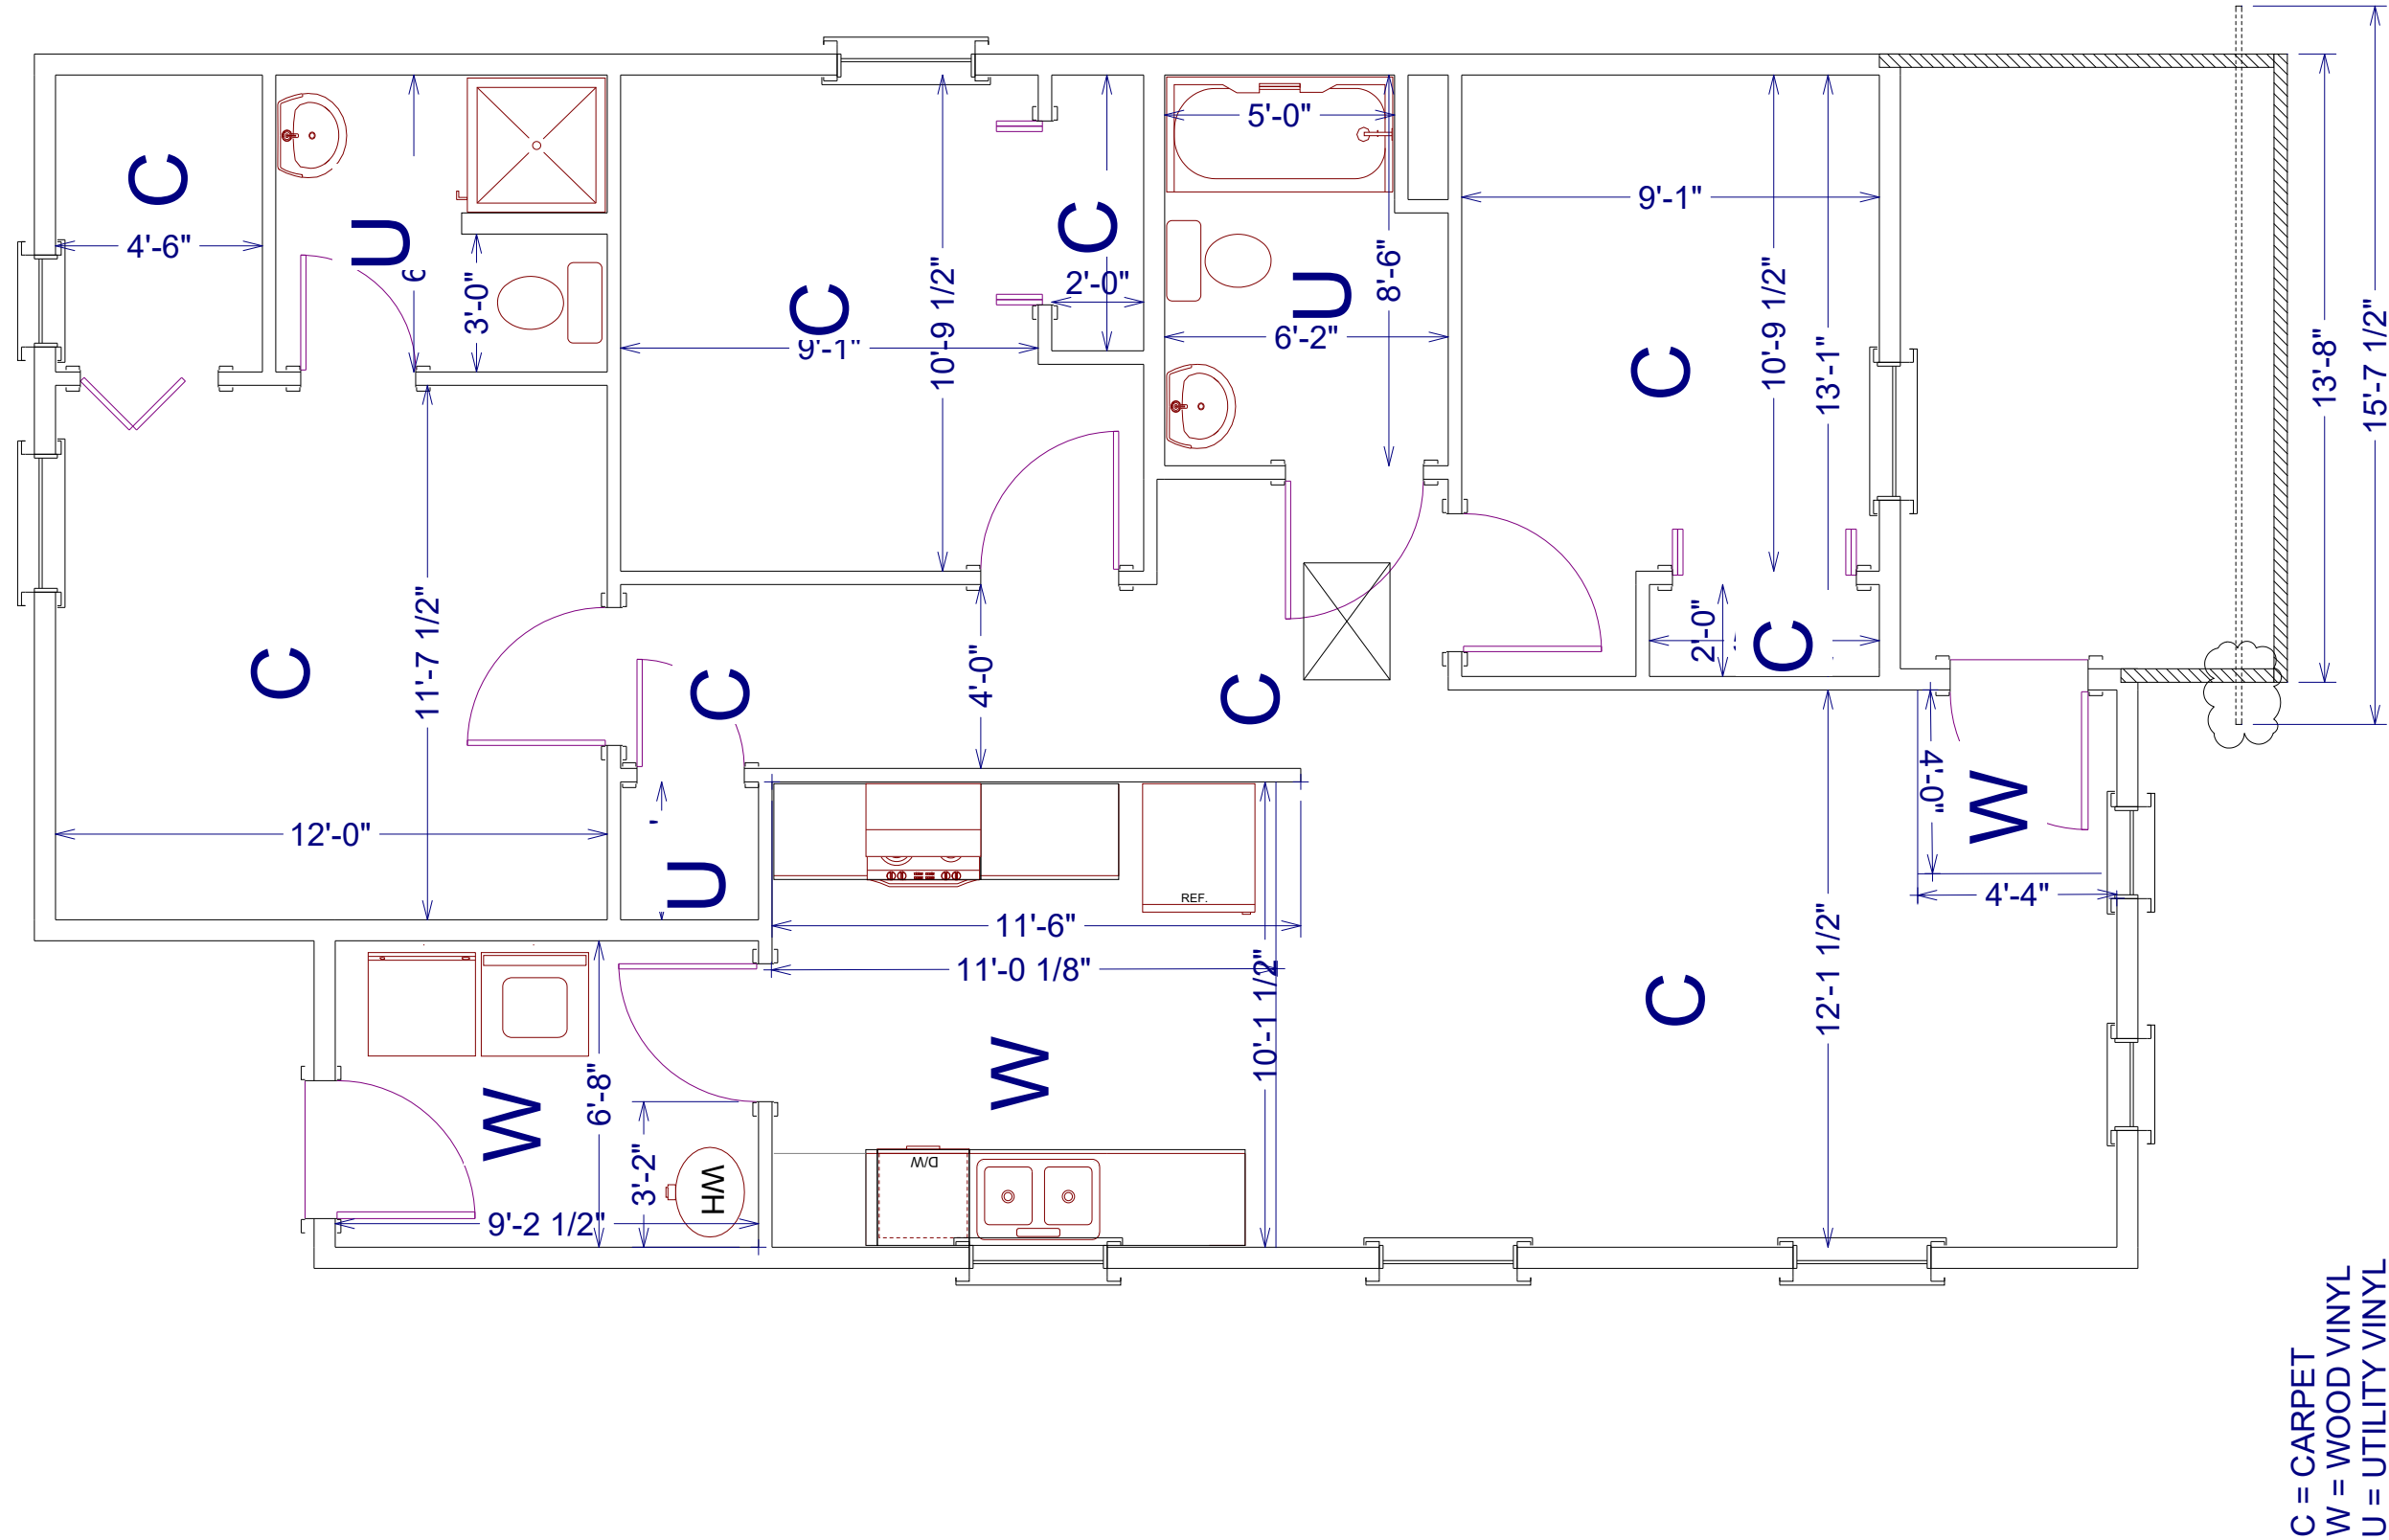

6/13/2019

A4

PARK PRESERVE FALL 2019

LOT 324: 4129 POLK FOREST CR

STYLE: PKP301

3 BEDROOM/2 BATHROOM

1097 sf

PERMIT NO.:
2019024808

HABITAT FOR HUMANITY

414 HARDING PLACE, SUITE 100

NASHVILLE, TN 37211


OFFICE: 615-254-HOME

FAX: 615-254-4645



A1

ELECTRICAL PLAN
SCALE: 1/4" = 1'-0"

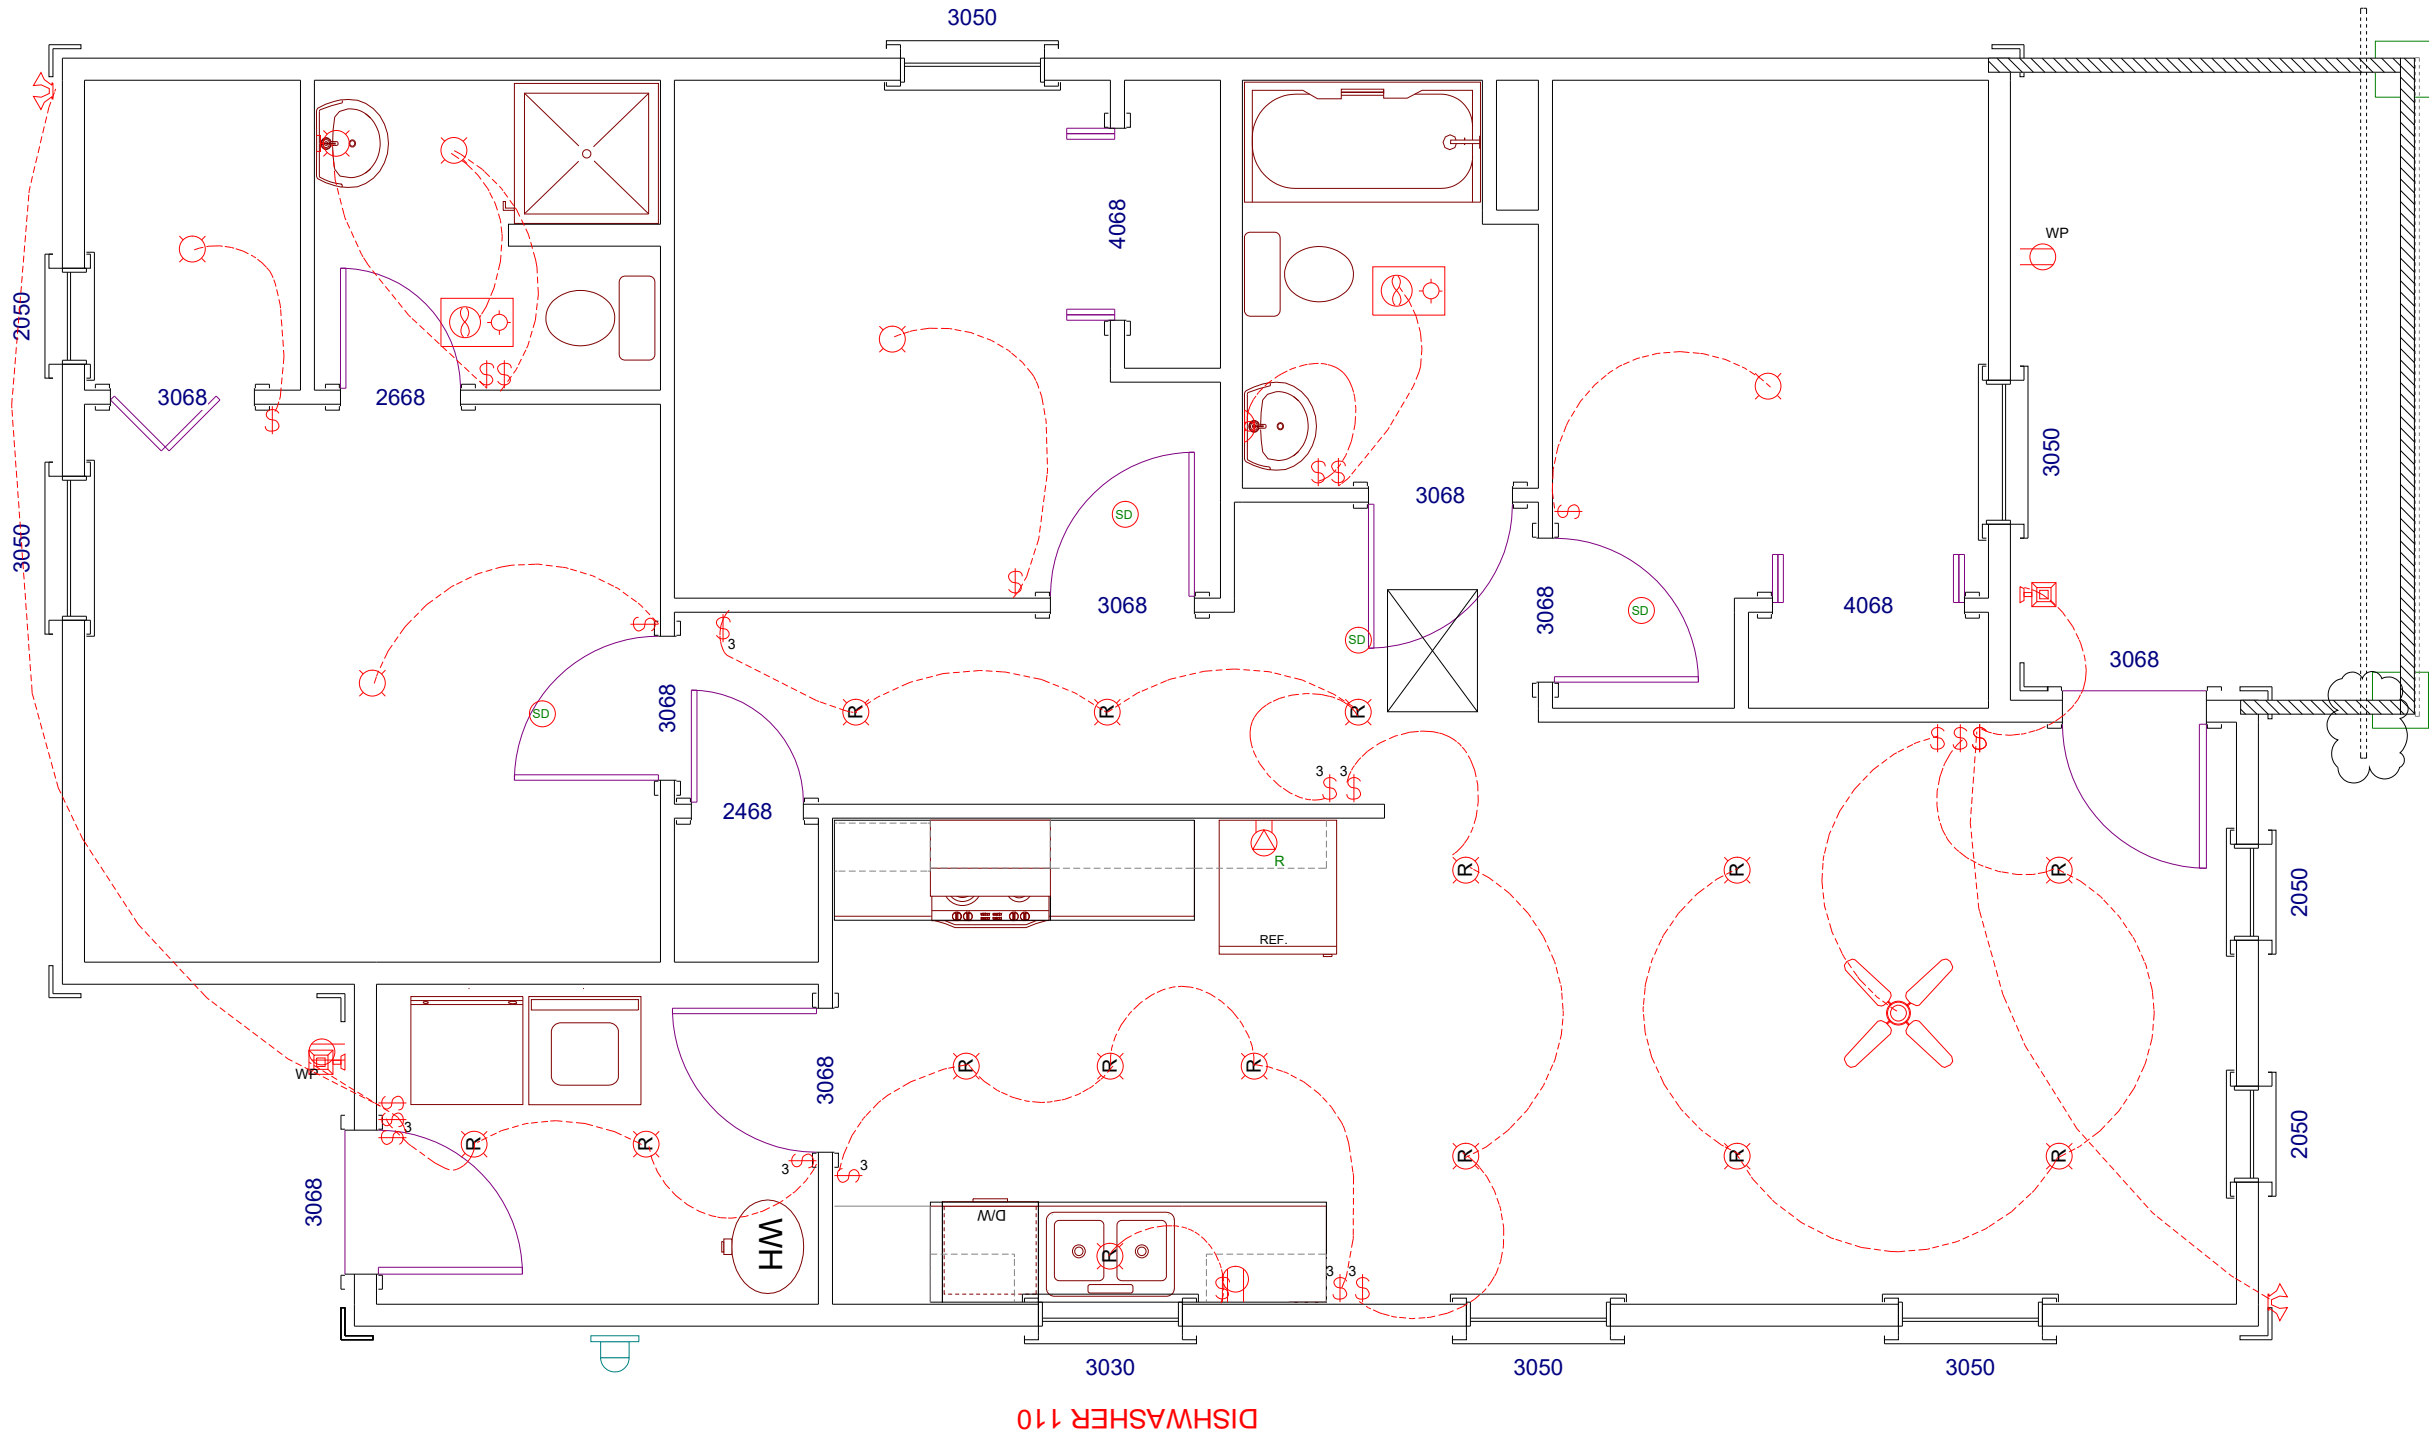

6/13/2019

A5

PARK PRESERVE FALL 2019

LOT 324: 4129 POLK FOREST CR

STYLE: PKP301





3 BEDROOM/2 BATHROOM

1097 sf

PERMIT NO.:
2019024808

HABITAT FOR HUMANITY
414 HARDING PLACE, SUITE 100
NASHVILLE, TN 37211
OFFICE: 615-254-HOME
FAX: 615-254-4645



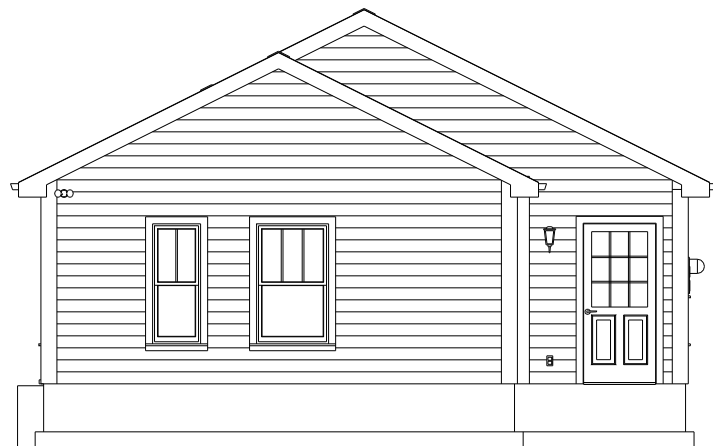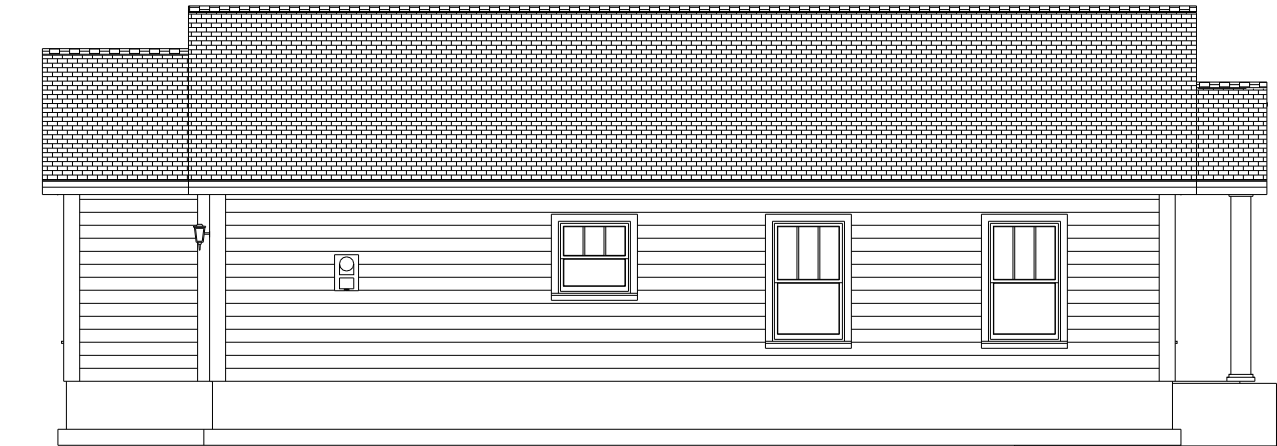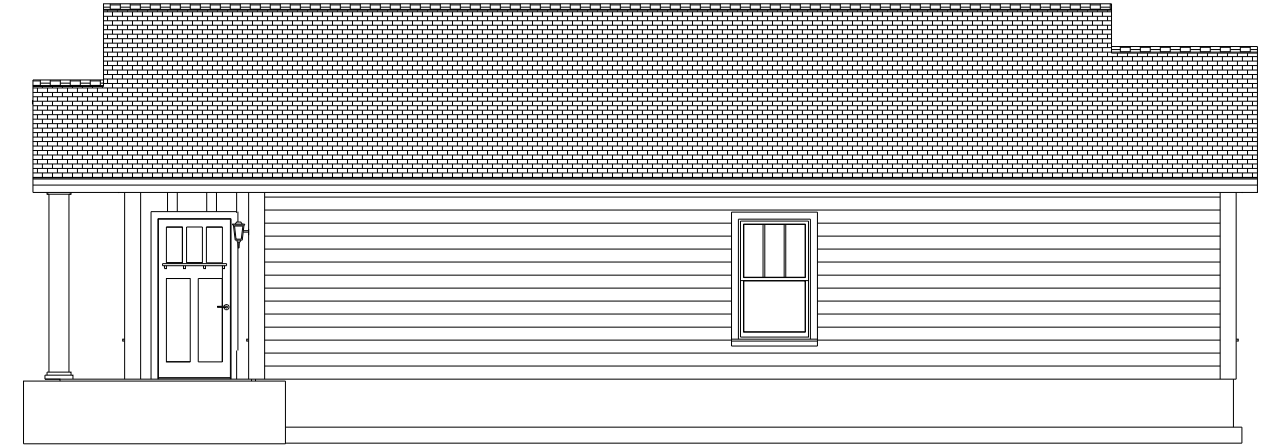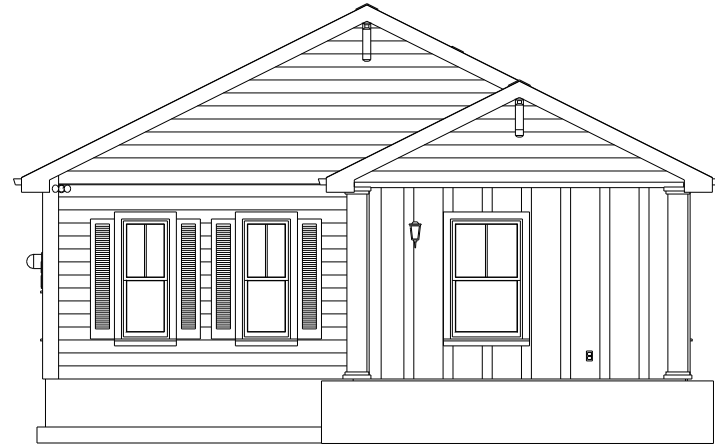

C4 **RIGHT ELEVATION**
SCALE: 1/8" = 1'-0"

C1 **LEFT ELEVATION**
SCALE: 1/8" = 1'-0"

A4 **FRONT ELEVATION**
SCALE: 1/8" = 1'-0"

A1 **REAR ELEVATION**
SCALE: 1/8" = 1'-0"



HABITAT FOR HUMANITY
414 HARDING PLACE, SUITE 100
NASHVILLE, TN 37211
OFFICE: 615-254-HOME
FAX: 615-254-4645

PARK PRESERVE FALL 2019
LOT 324: 4129 POLK FOREST CR
STYLE: PKP301
3 BEDROOM/2 BATHROOM
1097 sf
PERMIT NO.:
2019024808

6/13/2019

A6